


FIRE ALARM SYSTEM - SECOND FLOOR PLAN  
SCALE: 3/32" = 1'-0"

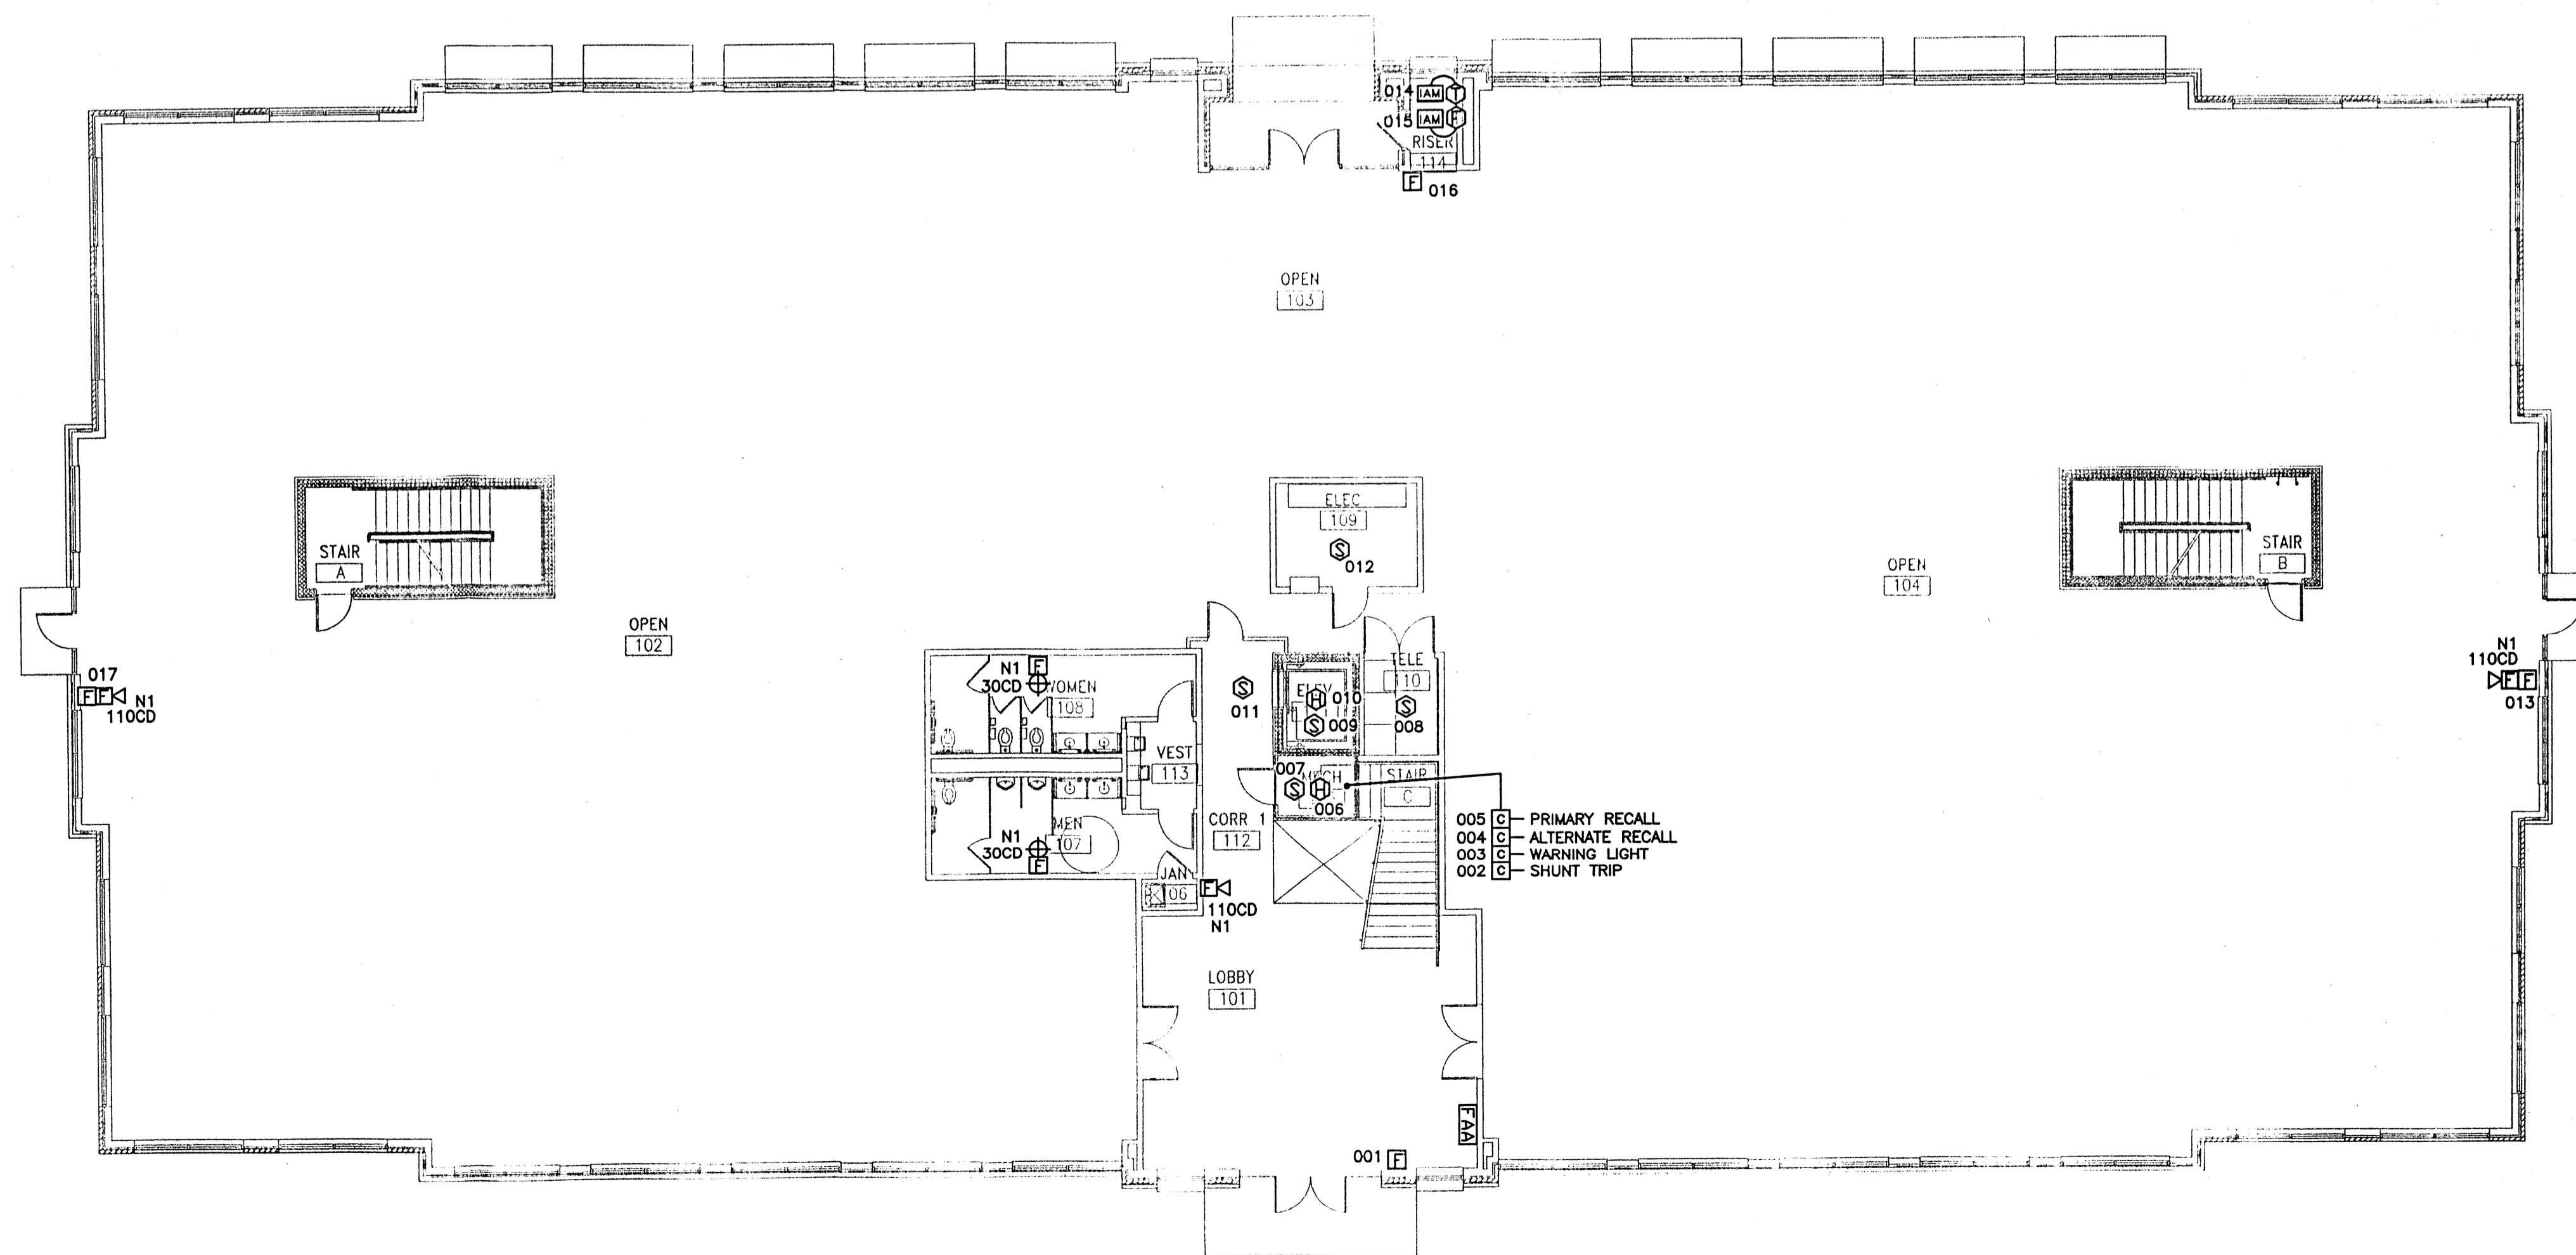

FIRE ALARM SYSTEM - FIRST FLOOR PLAN  
SCALE: 3/32" = 1'-0"

- 005 □ - PRIMARY RECALL
- 004 □ - ALTERNATE RECALL
- 003 □ - WARNING LIGHT
- 002 □ - SHUNT TRIP

**tyco** Fire & Security  
SimplexGrinnell

3888 LEEDS AVENUE  
CHARLESTON, SC 29405  
SALES: 843-747-5254  
SERVICE: 843-747-5254  
FAX: 843-747-5266

©2003 SIMPLEXGRINNELL LP  
ALL RIGHTS RESERVED

NO.	DATE	REVISION DESCRIPTION

**FIRE ALARM SYSTEM  
FIRST & SECOND FLOOR PLAN**

**BELLE HALL OFFICE BLDG**

DRAWN BY:	DATE:
DESIGNED BY: CED	DATE: 8-8-06
APPROVED BY: DWP	DATE: 8-8-06
PROJECT NUMBER:	
SHEET TITLE: BHOFF01	
SHEET NUMBER: BHOFF01	