




DISCONNECT SWITCH SCHEDULE (THIS SHEET ONLY)	
SYMBOL	DESCRIPTION
◇	30/2/1/NF
◇	30/3/1/NF
◇	30/3/1/20AF

WIRE & CONDUIT SCHEDULE (THIS SHEET ONLY)	
SYMBOL	DESCRIPTION
(A)	2#12, 1#12G, 1/2"C
(B)	3#12, 1#12G, 1/2"C
(C)	3#10, 1#10G, 3/4"C
(D)	2#10, 1#10G, 3/4"C

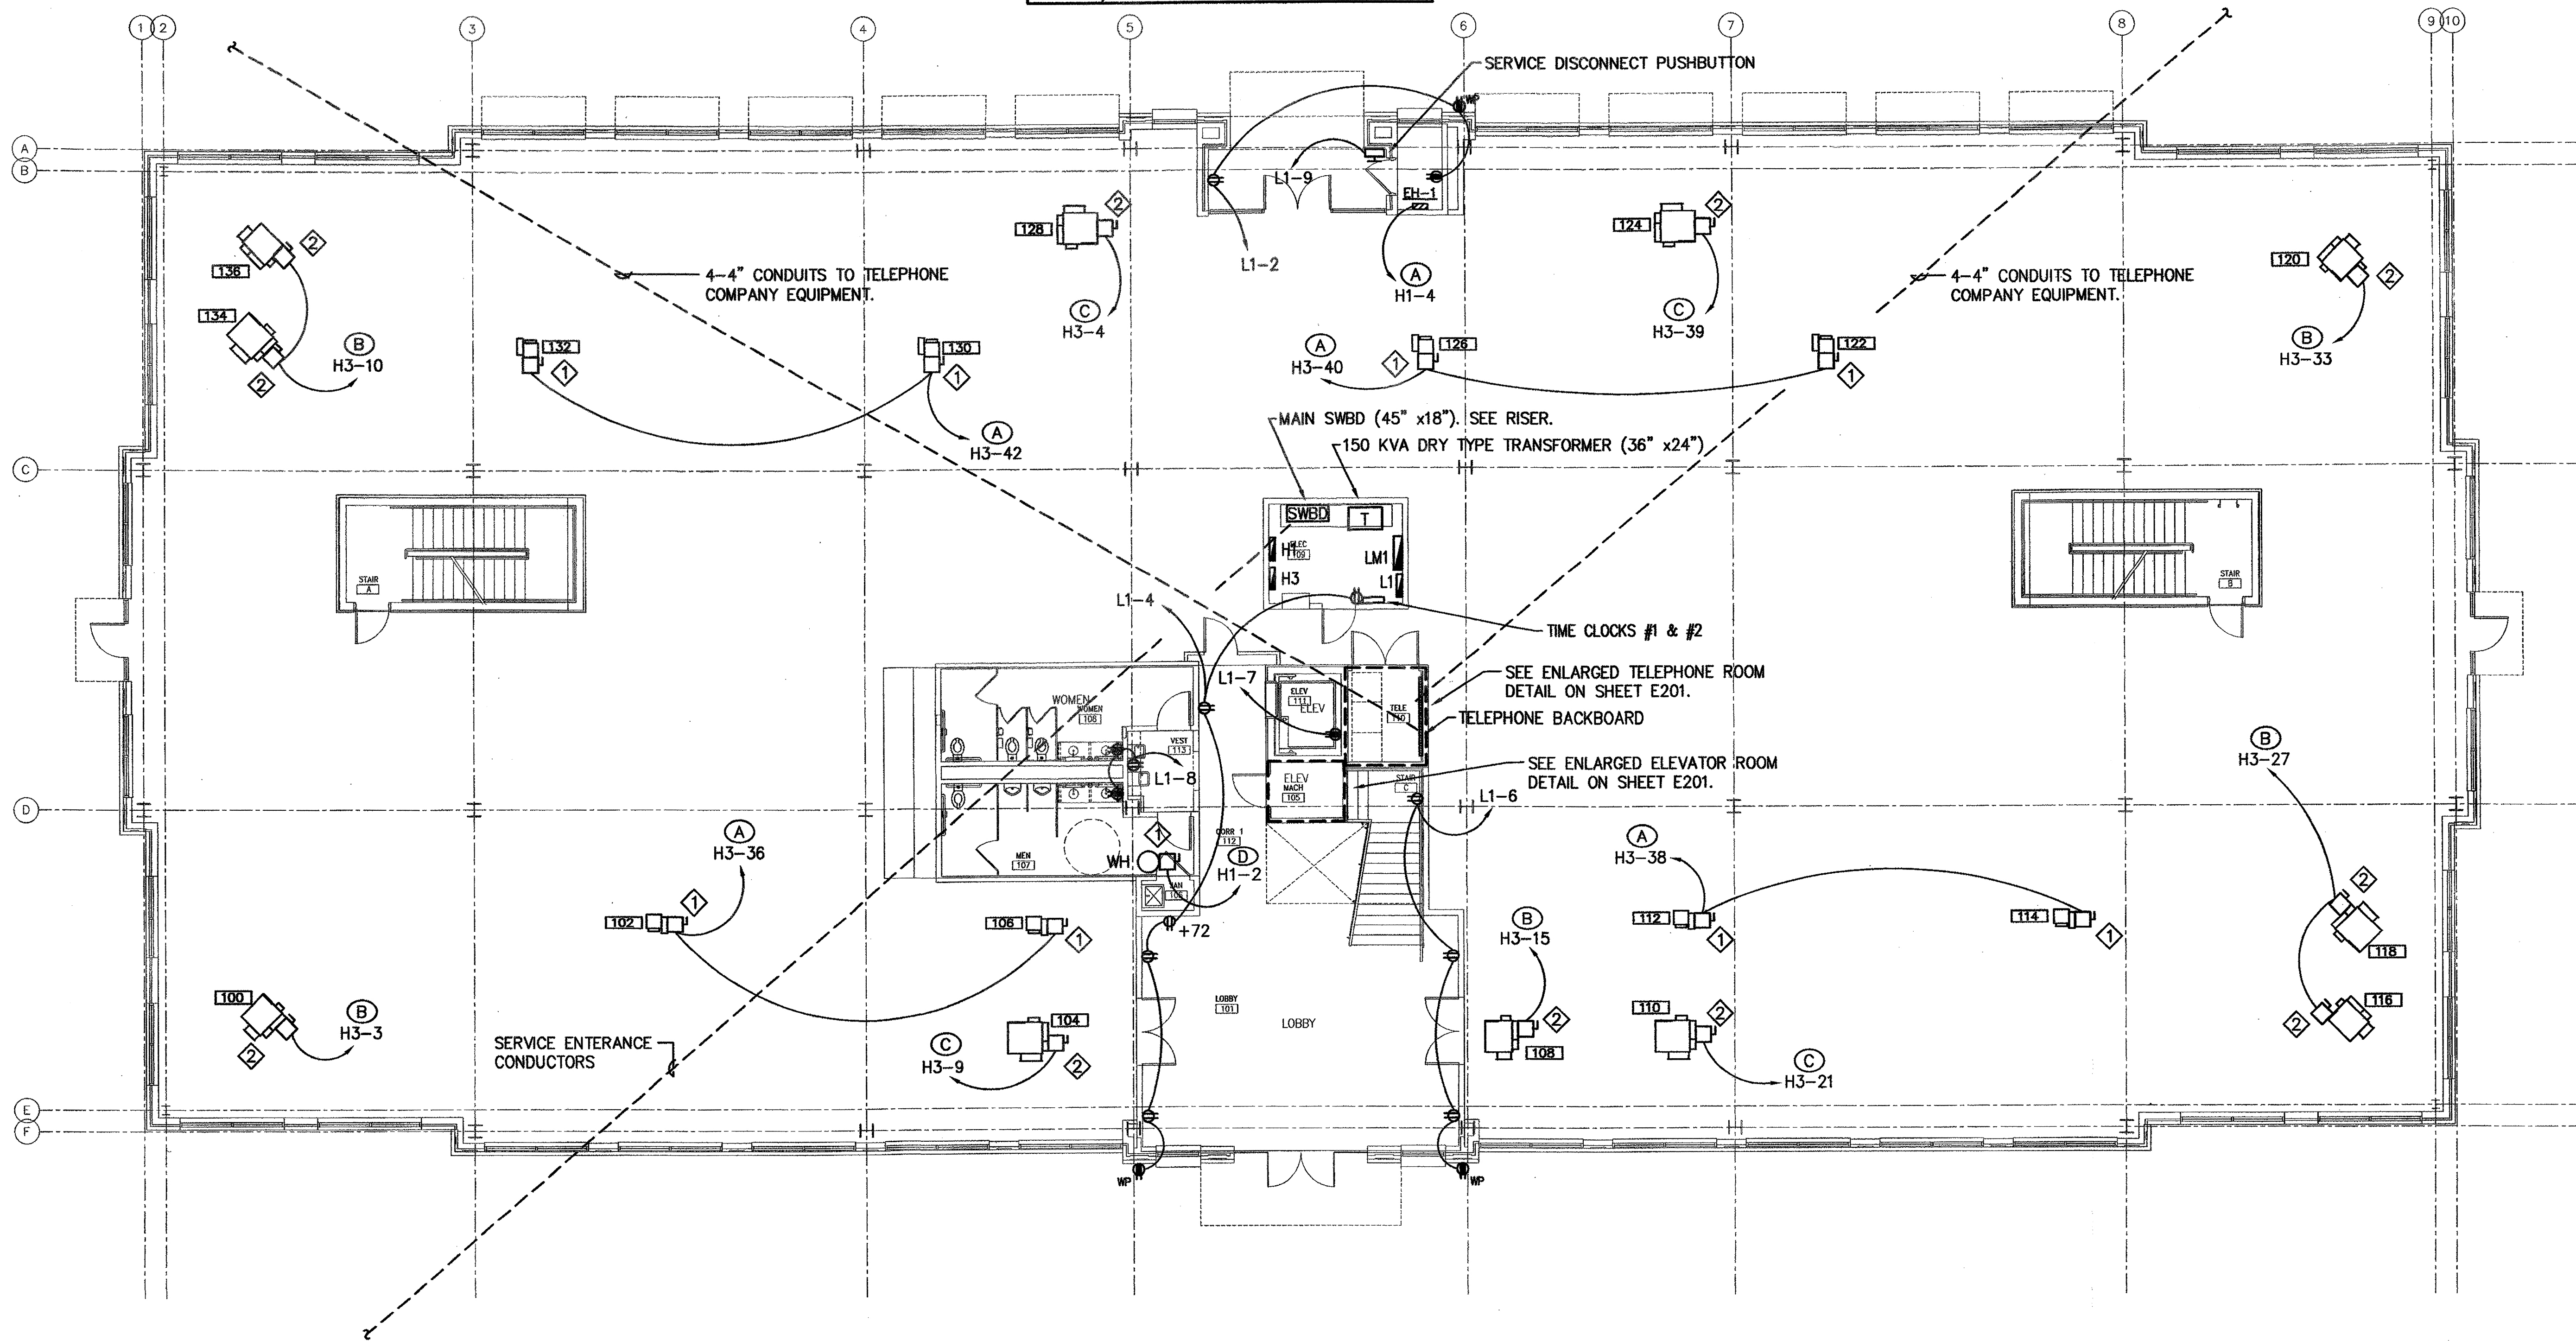

FIRST FLOOR POWER PLAN
SCALE: 1/8"=1'-0"

THE TIME CLOCKS SHALL BE PROGRAMMABLE ELECTRONIC 7 DAY ASTRONOMIC TIME SWITCHES TO TURN LIGHTING ON AT DUSK AND OFF AT A PRESELECTED TIME. PROVIDE A BATTERY OR SPRING OPERATED 24 HOUR POWER BACKUP AND FOUR 120V, 20A CONTACTS. PROVIDE IN NEMA 1 ENCLOSURE. INTERMATIC MODEL ET70215C OR EQUAL.

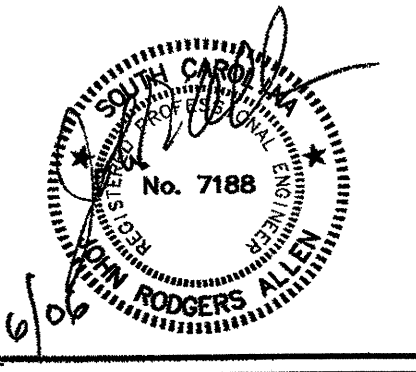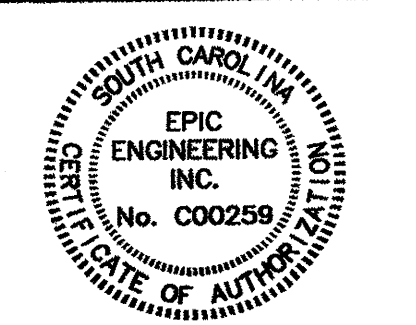

EPIC ENGINEERING INC.
P.O. BOX 2138 • MT. PLEASANT, SC 29465
(843) 649-6976 EPIC JOB NO. 05176
DESIGNED BY: JRA
DRAWN BY: RAD
APPROVED BY: JRA
CHECKED BY: JRA

REVISIONS	
△	DESCRIPTION
	DATE REVISION
△	DESCRIPTION
	DATE REVISION
△	DESCRIPTION
	DATE REVISION

**OFFICES AT BELLE HALL
BUILDINGS 1 & 2**
LONG POINT ROAD
MOUNT PLEASANT, SC
PROJECT TITLE

**FIRST FLOOR
POWER PLAN**
DRAWING TITLE

SHEET NUMBER
E103 OF 10
CAD FILE NAME:
05176E103
SCALE: 1/8"=1'-0"
DATE: 1/06/06
© EPIC ENGINEERING 2006