

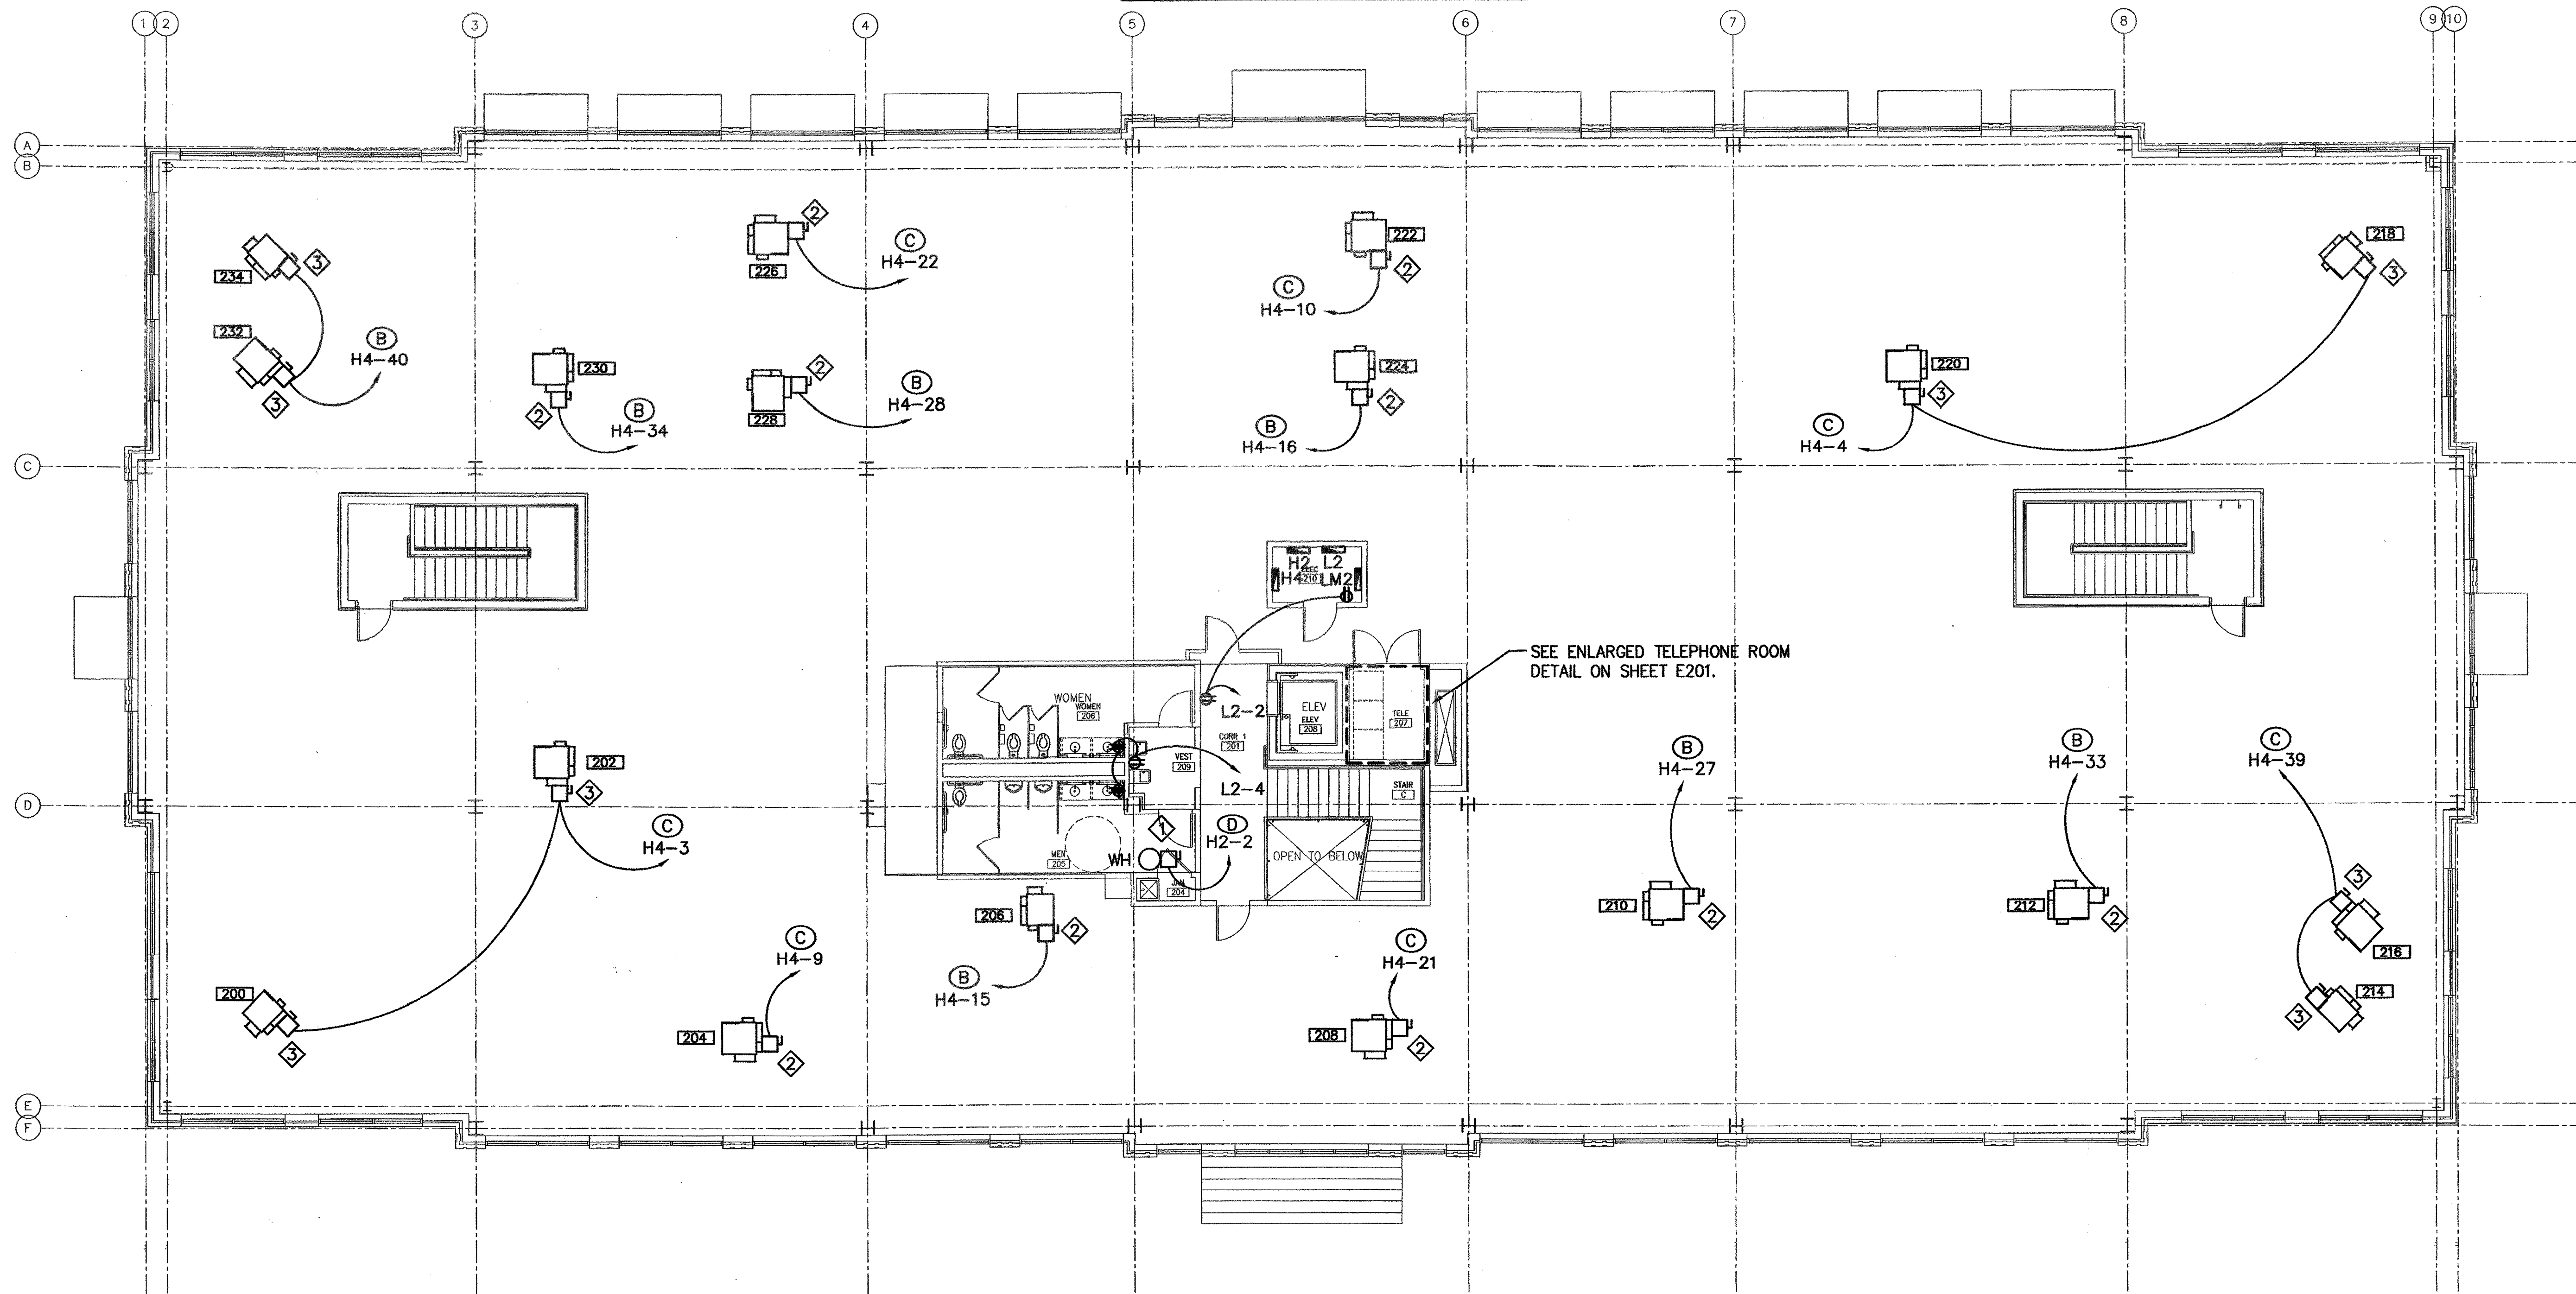


DISCONNECT SWITCH SCHEDULE (THIS SHEET ONLY)	
SYMBOL	DESCRIPTION
◇	30/2/1/NF
◇	30/3/1/NF
◇	30/3/1/20AF

WIRE & CONDUIT SCHEDULE (THIS SHEET ONLY)	
SYMBOL	DESCRIPTION
Ⓐ	2#12, 1#12G, 1/2"C
Ⓑ	3#12, 1#12G, 1/2"C
Ⓒ	3#10, 1#10G, 3/4"C
Ⓓ	2#10, 1#10G, 3/4"C

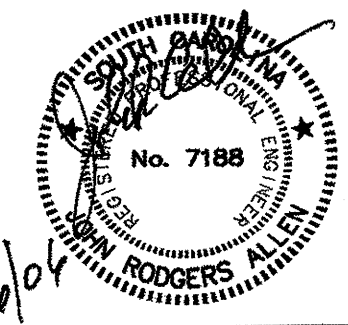

SECOND FLOOR POWER PLAN
SCALE: 1/8"=1'-0"

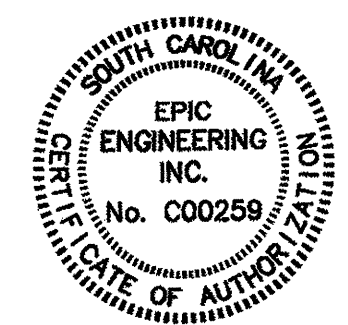

EPIC ENGINEERING INC.	
P.L. TRACY, P.E. - M.T. WYATT, P.E. - SC. GRADE	
(843) 849-8878 EPIC JOB NO. 05178	
COPYRIGHT © 2006. THIS DOCUMENT IS THE PROPERTY OF EPIC ENGINEERING, INC. ANY UNAUTHORIZED REPRODUCTION OR USE OF THIS DOCUMENT IS STRICTLY PROHIBITED.	
DESIGNED BY: JRA	APPROVED BY: JRA
DRAWN BY: RAD	CHECKED BY: JRA

REVISIONS	
△	DESCRIPTION:
△	DATE REVISION:
△	DESCRIPTION:
△	DATE REVISION:
△	DESCRIPTION:
△	DATE REVISION:

**OFFICES AT BELLE HALL
BUILDINGS 1 & 2**
LONG POINT ROAD
MOUNT PLEASANT, SC
PROJECT TITLE

SECOND FLOOR POWER PLAN	DRAWING TITLE
SCALE: 1/8"=1'-0"	DATE: 1/06/06

SHEET NUMBER	E104 OF 10
CAD FILE NAME:	05178E104
© EPIC ENGINEERING 2006	