


SECOND FLOOR FIRE ALARM PLAN
 SCALE: 1/8" = 1'-0"

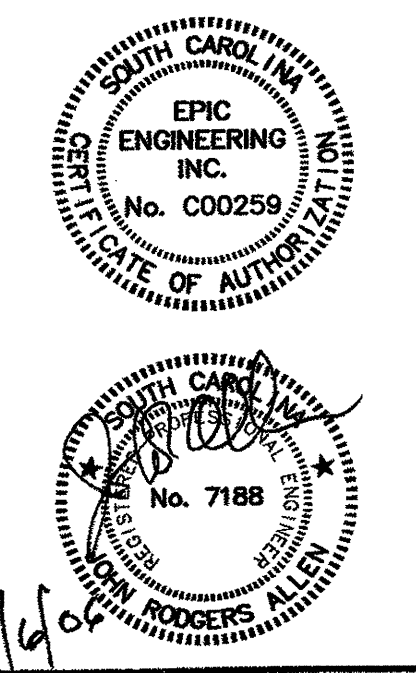

EPIC ENGINEERING INC.
 P.O. BOX 2132 • MT. PLEASANT, SC 29485
 (843) 949-0879 EPIC JOB NO. 05176
THIS DOCUMENT IS THE PROPERTY OF EPIC ENGINEERING INC. AND IS TO BE USED ONLY FOR THE PROJECT AND SITE SPECIFICALLY IDENTIFIED HEREIN. ANY REPRODUCTION OR USE IN VIOLATION OF THESE TERMS IS PROHIBITED AND SUBJECT TO LEGAL PROSECUTION.

DESIGNED BY:	JRA	APPROVED BY:	JRA
DRAWN BY:	RAD	CHECKED BY:	JRA

REVISIONS	
NO.	DESCRIPTION

**OFFICES AT BELLE HALL
 BUILDINGS 1 & 2**
 LONG POINT ROAD
 MOUNT PLEASANT, SC
 PROJECT TITLE

**SECOND FLOOR
 FIRE ALARM PLAN**
 DRAWING TITLE

SCALE:	1/8" = 1'-0"
DATE:	1/05/06

SHEET NUMBER
FA102 of 3

CAD FILE NAME:
05176FA102

© EPIC ENGINEERING 2006