



MECHANICAL ROOF PLAN
SCALE: 1/8"=1'-0"

REVISIONS		
No.	Date	Description

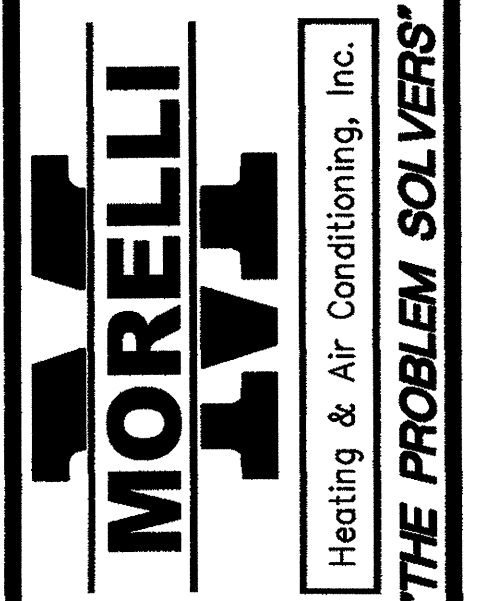


Job Number : 105261
 Designed : 11/11/05
 Plot Date : 01/09/06
 Drawn : AKK
 Approved By : JTH

THIS DRAWING IS THE PROPERTY OF MECHANICAL ENGINEERING CONSULTING ASSOCIATES, INC. UNAUTHORIZED USE OF ANY KIND, INCLUDING USE ON OTHER PROJECTS IS PROHIBITED.

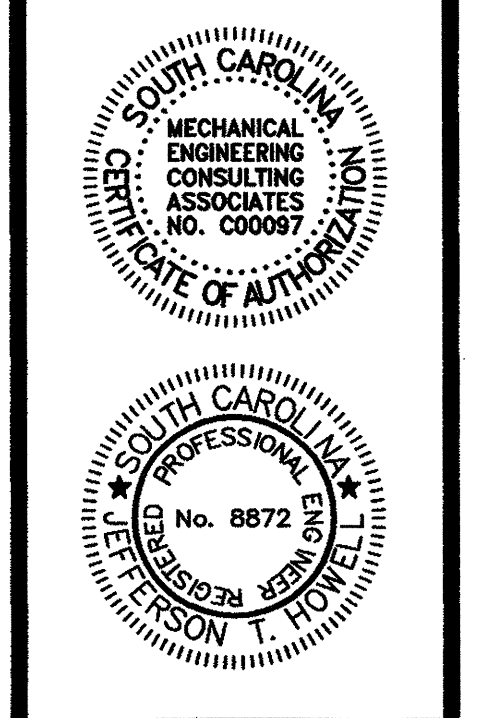

Project **OFFICES AT BELLE HALL BUILDING TWO MOUNT PLEASANT, SC**
 Sheet Title **MECHANICAL ROOF PLAN**

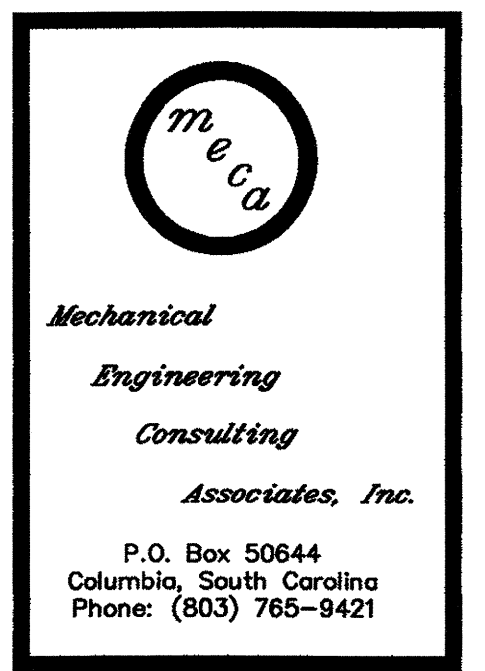

Sheet No. **M103**
 of 7
 Project No. **105261**

PERMIT SET