

REVISIONS		
No.	Date	Description

**MORELLI**  
Heating & Air Conditioning, Inc.  
**THE PROBLEM SOLVERS**


Job Number : 105261  
Designed : 11/11/05  
Plot Date : 24 May 2006  
Drawn by :  
Approved By :

THIS DRAWING IS THE PROPERTY OF MECHANICAL ENGINEERING CONSULTING ASSOCIATES, INC. UNAUTHORIZED USE OF ANY KIND, INCLUDING USE ON OTHER PROJECTS IS PROHIBITED.

Project  
**OFFICES AT BELLE HALL  
BUILDING TWO  
MOUNT PLEASANT, SC**  
Sheet Title  
**FIRST FLOOR PLUMBING**

**mecc**  
Mechanical  
Engineering  
Consulting  
Associates, Inc.  
P.O. Box 50644  
Columbia, South Carolina  
Phone: (803) 765-9421

Sheet No. **P1.1**  
of 5  
Project No. **105261**

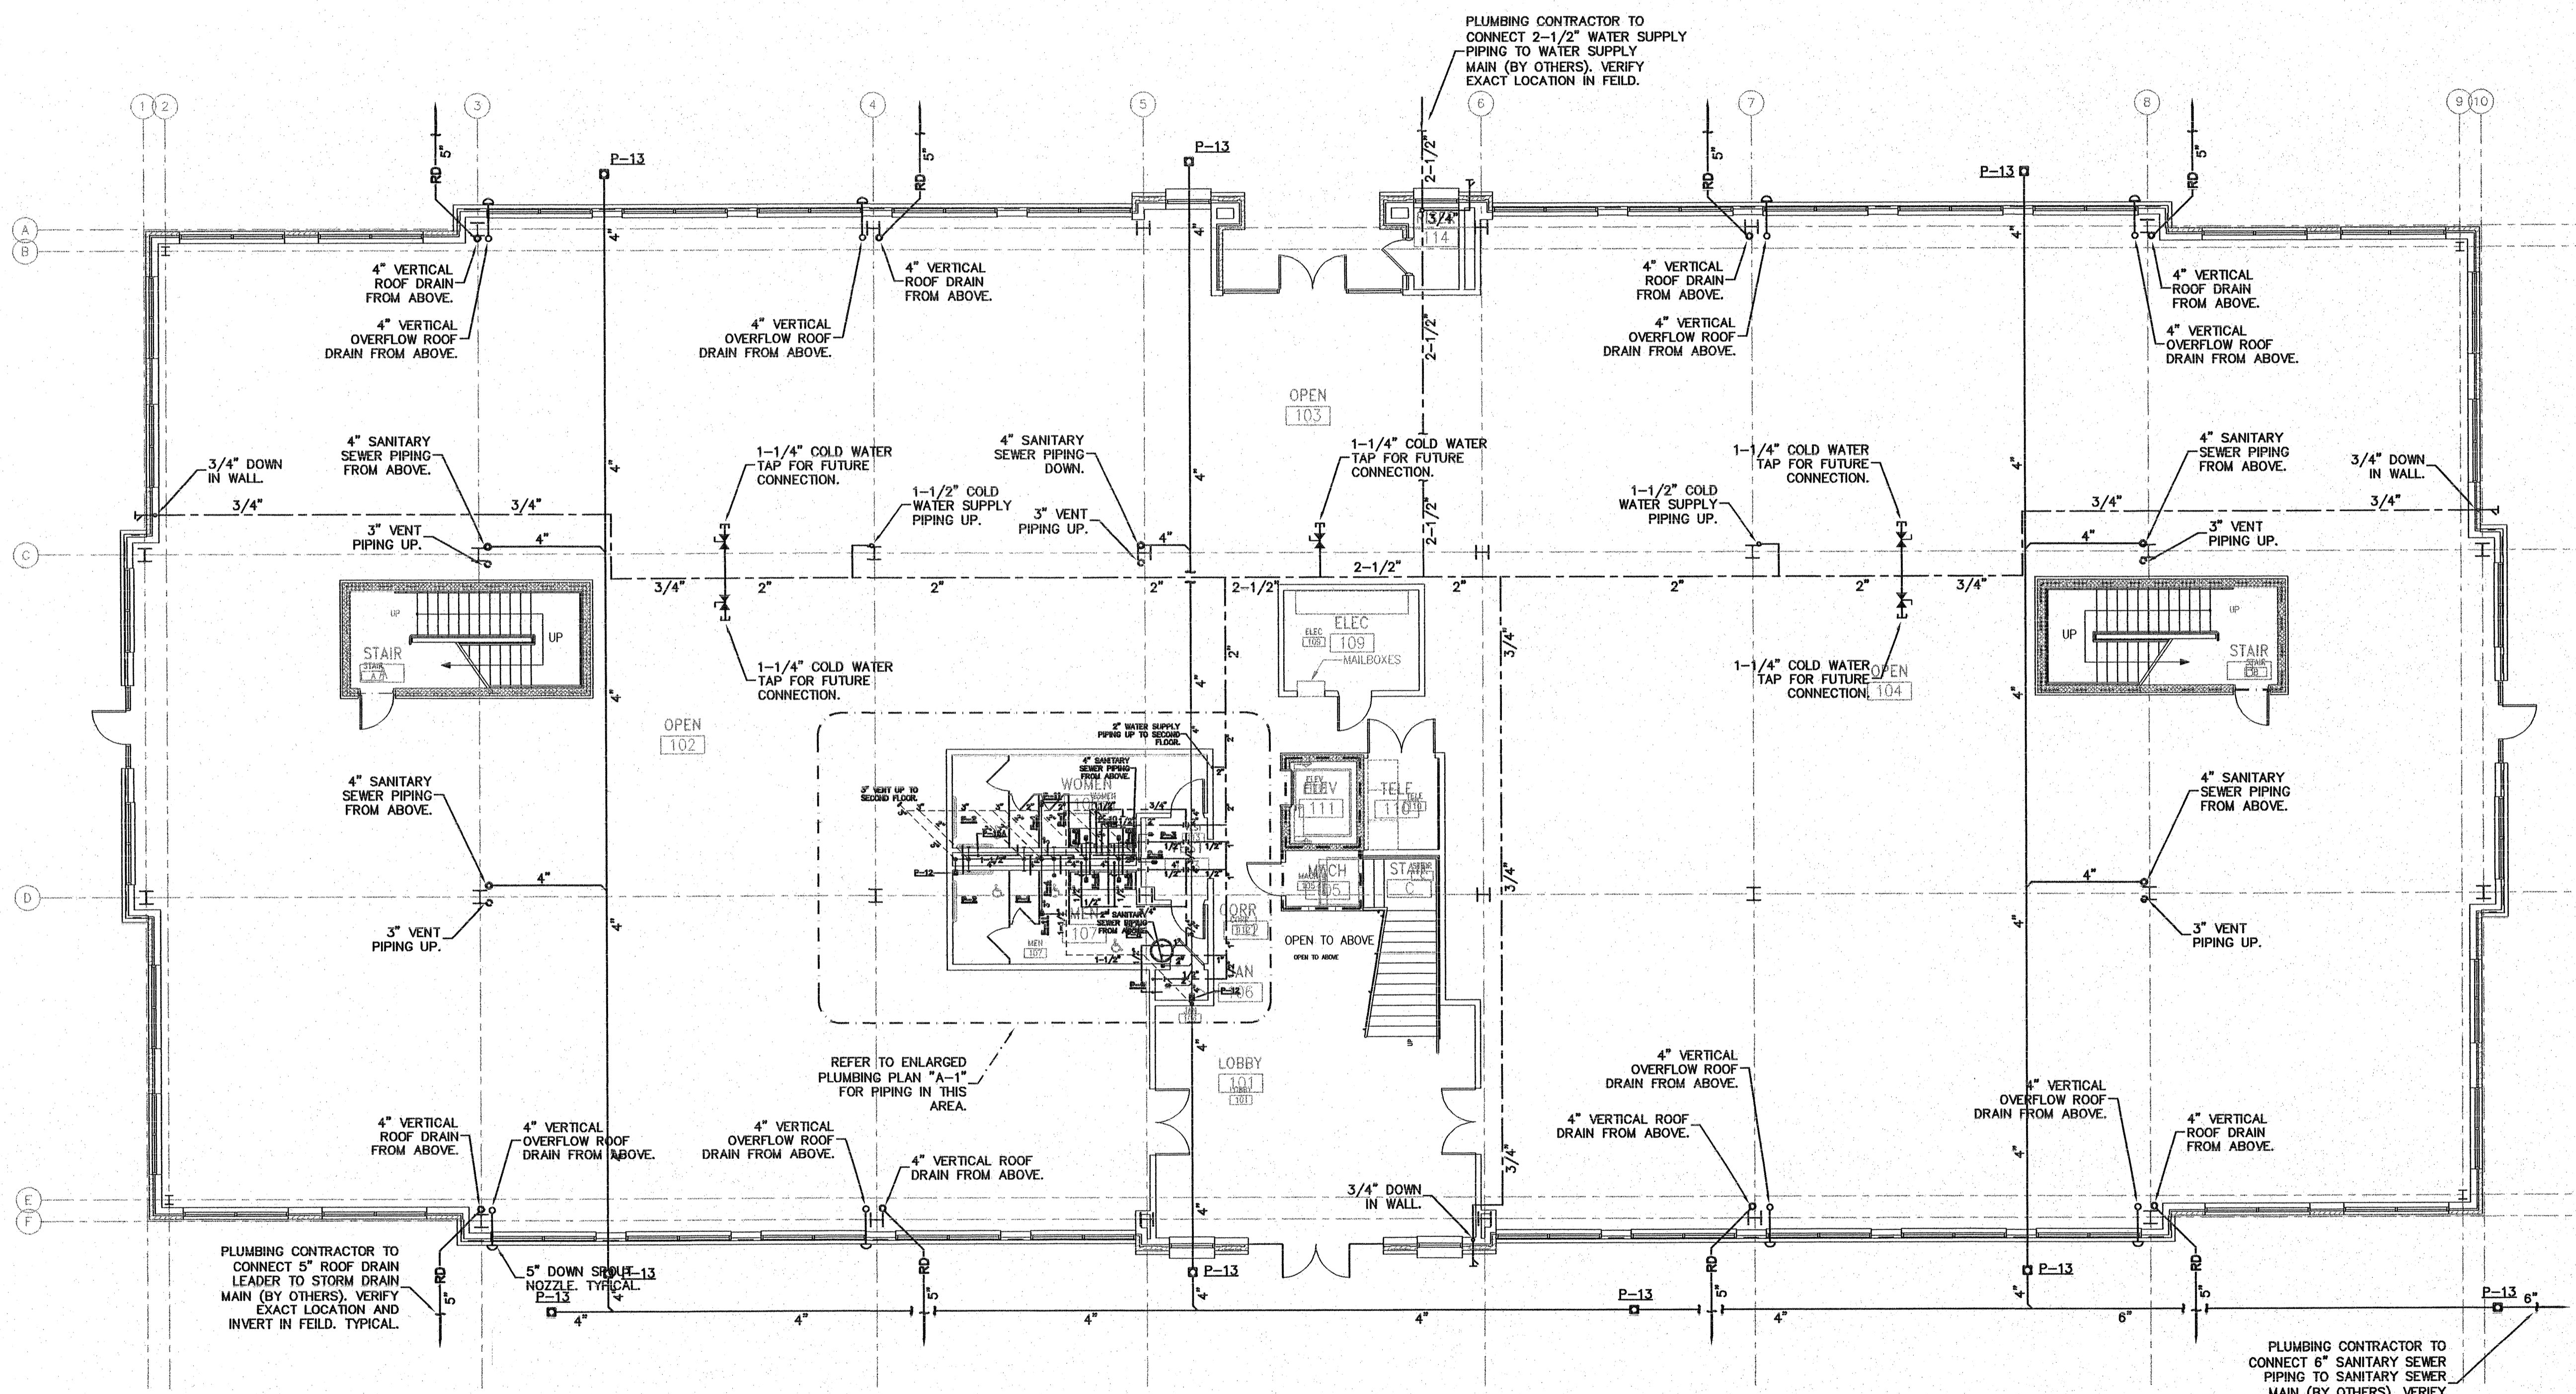

**OVERALL FIRST FLOOR PLUMBING PLAN**  
SCALE: 1/8" = 1' - 0"