



REVISIONS		
No.	Date	Description

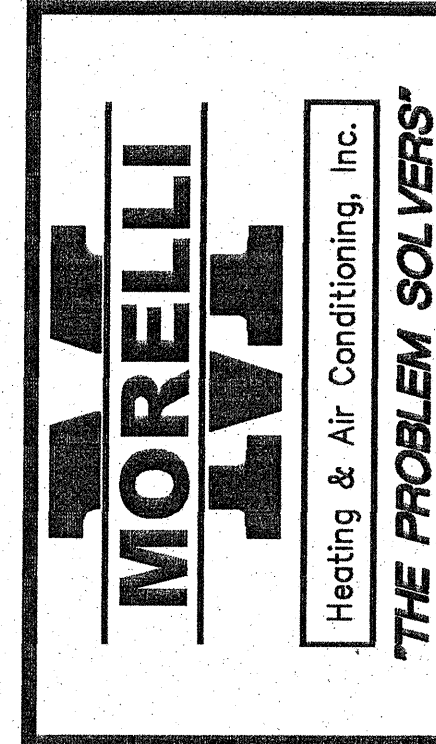

Job Number : 105261
 Designed : 11/11/05
 Plot Date : 27 April 2006
 Drawn :
 Approved By :


THIS DRAWING IS THE PROPERTY OF MECHANICAL ENGINEERING CONSULTING ASSOCIATES, INC. UNAUTHORIZED USE OF ANY KIND, INCLUDING USE ON OTHER PROJECTS IS PROHIBITED.

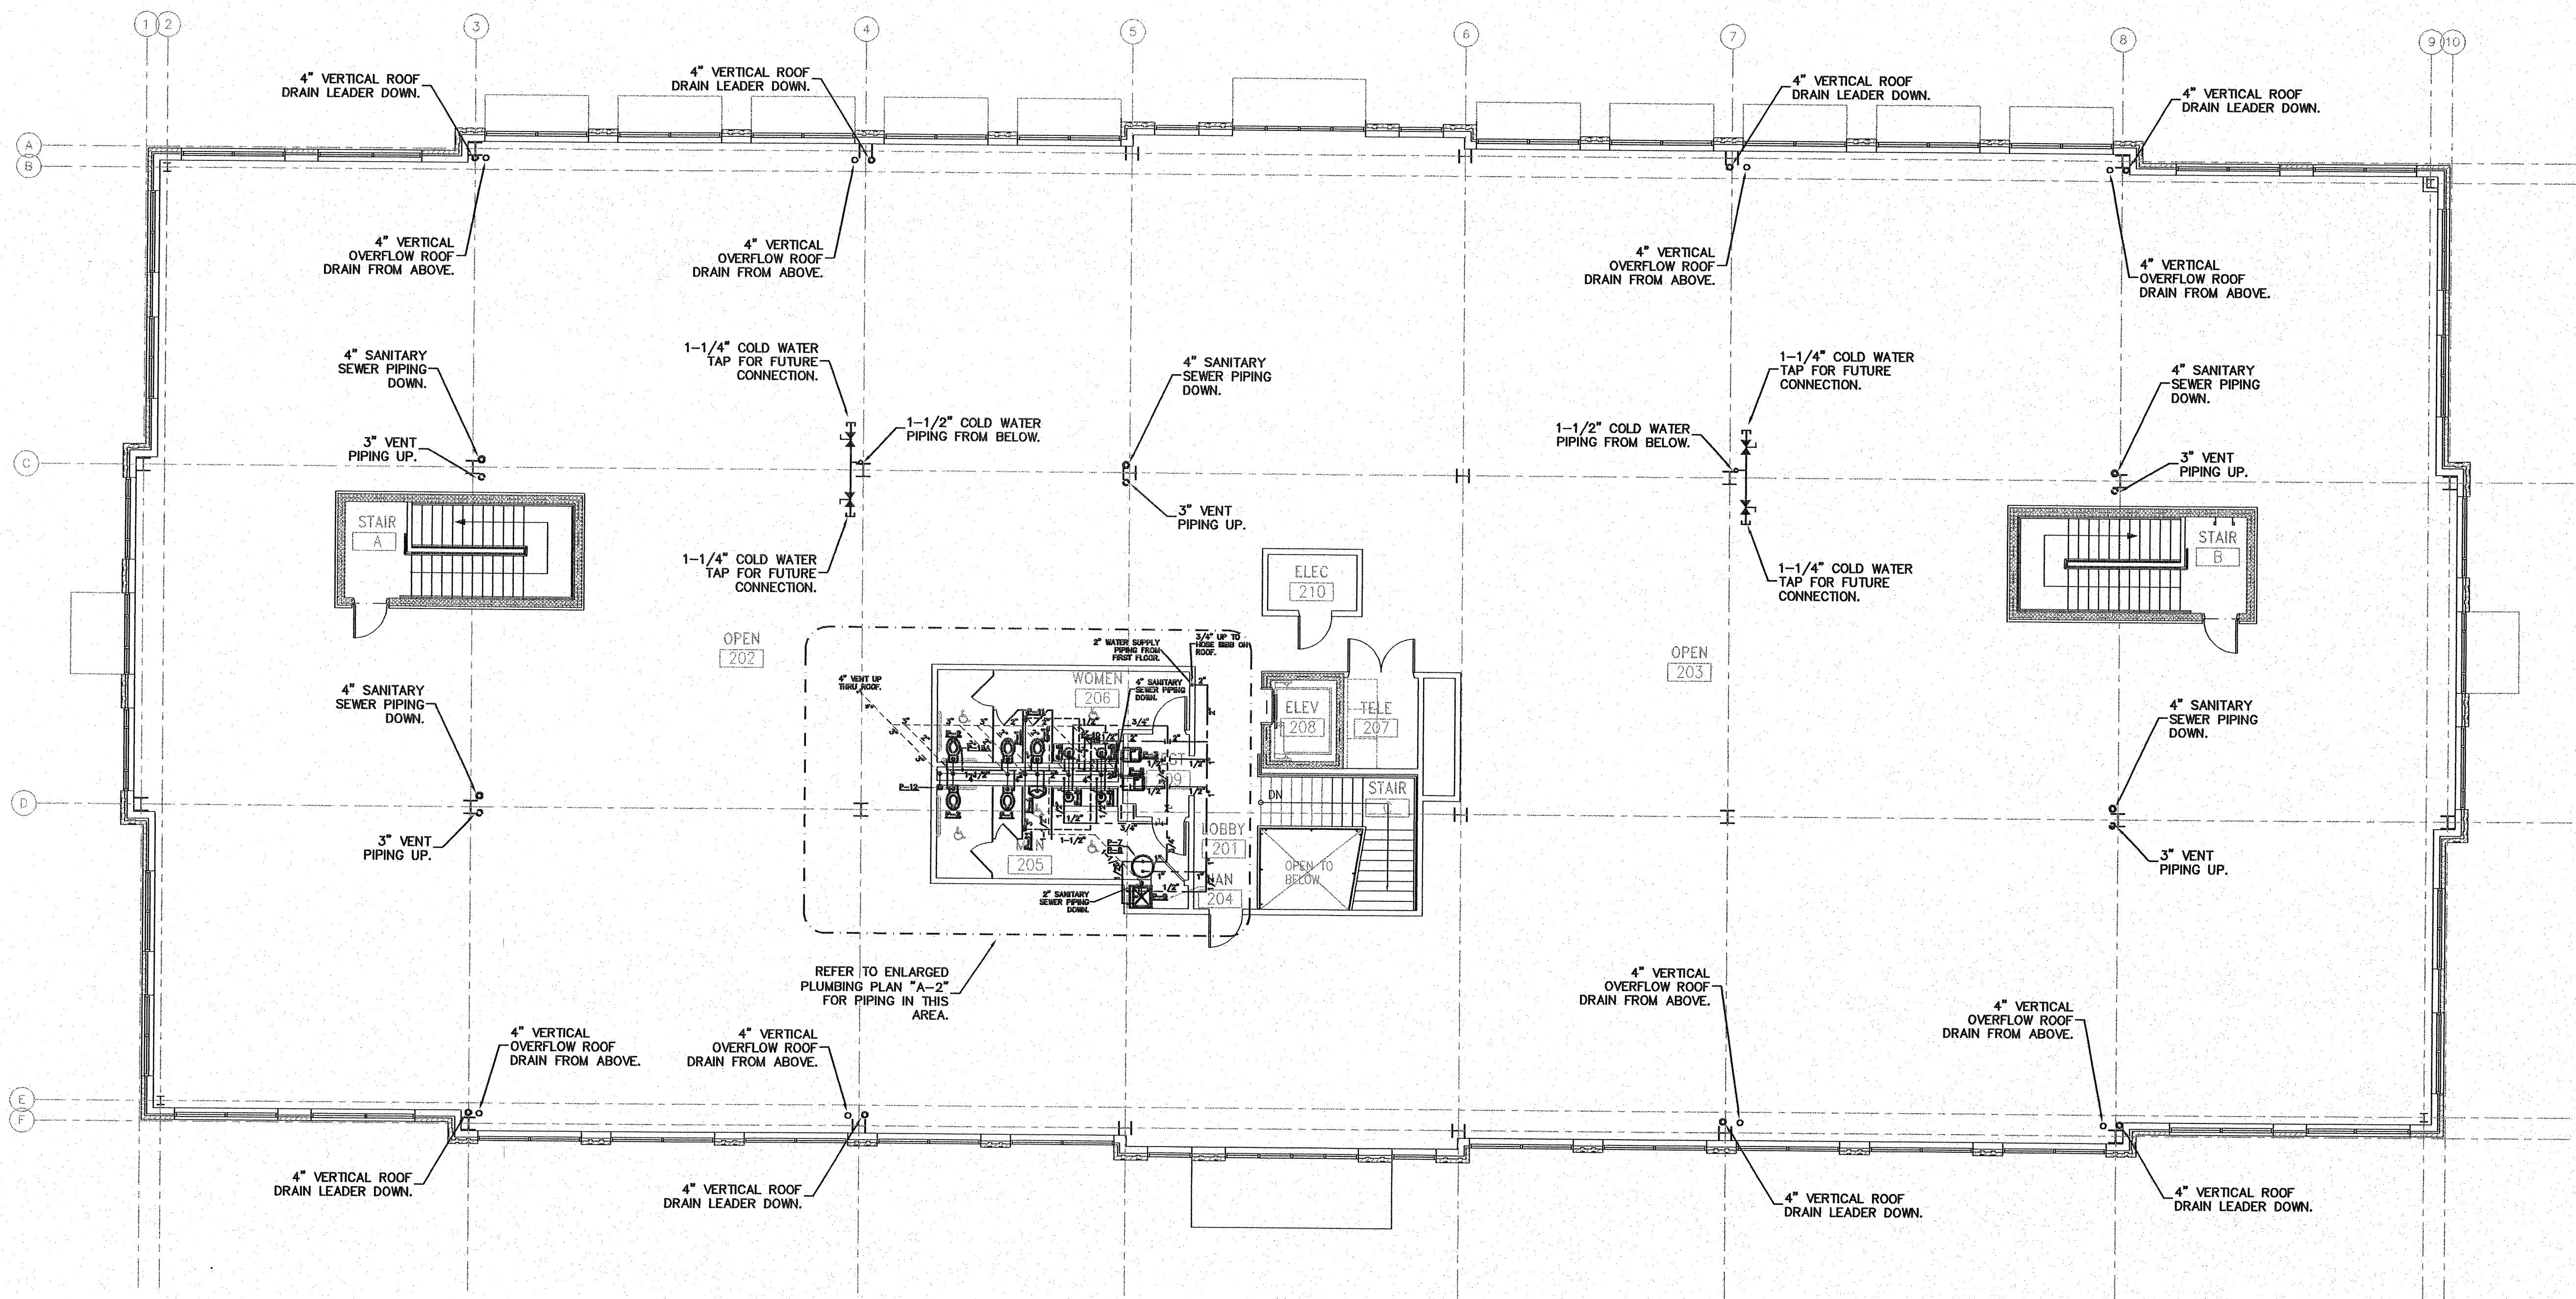

OVERALL SECOND FLOOR PLUMBING PLAN

SCALE: 1/8" = 1' - 0"

Project
**OFFICES AT BELLE HALL
 BUILDING TWO
 MOUNT PLEASANT, SC**
 Sheet
SECOND FLOOR PLUMBING

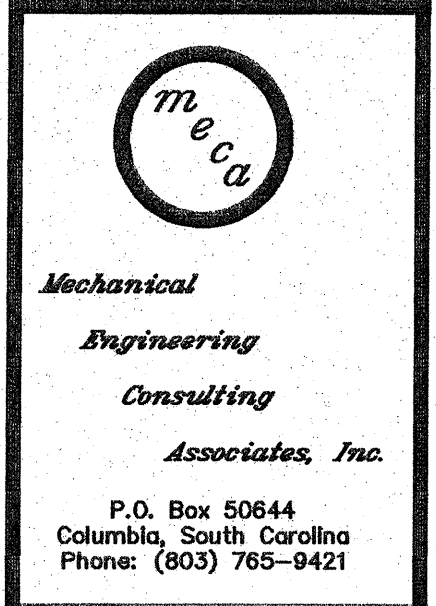

Sheet No. **P1.2**
 of 5
 Project No. **105261**