



| REVISIONS |      |             |
|-----------|------|-------------|
| No.       | Date | Description |
|           |      |             |
|           |      |             |
|           |      |             |

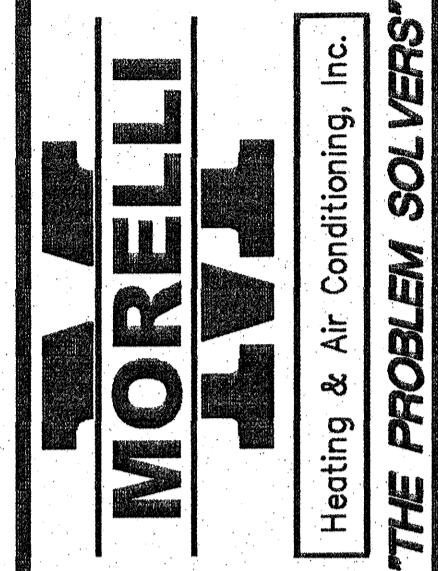

Job Number : 105261  
 Designed : 11/11/05  
 Plot Date : 27 April 2006  
 Drawn :  
 Approved By :


THIS DRAWING IS THE PROPERTY OF MECHANICAL ENGINEERING CONSULTING ASSOCIATES, INC. UNAUTHORIZED USE OF ANY KIND, INCLUDING USE ON OTHER PROJECTS IS PROHIBITED.

Project OFFICES AT BELLE HALL BUILDING TWO MOUNT PLEASANT, SC  
 Sheet Title PLUMBING ROOF PLAN

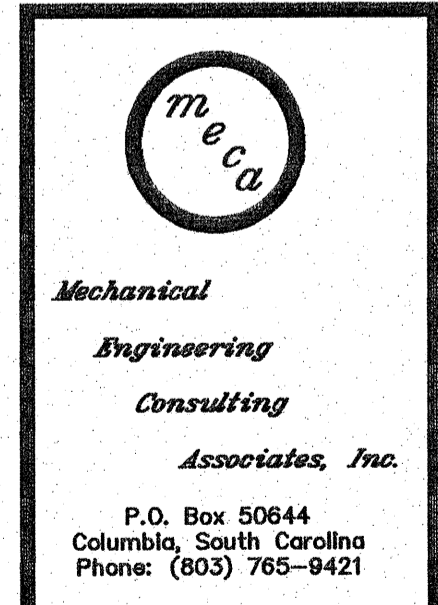

Sheet No. **P1.3**  
 of 5  
 Project No. **105261**

RECEIVED MAR 08 2007

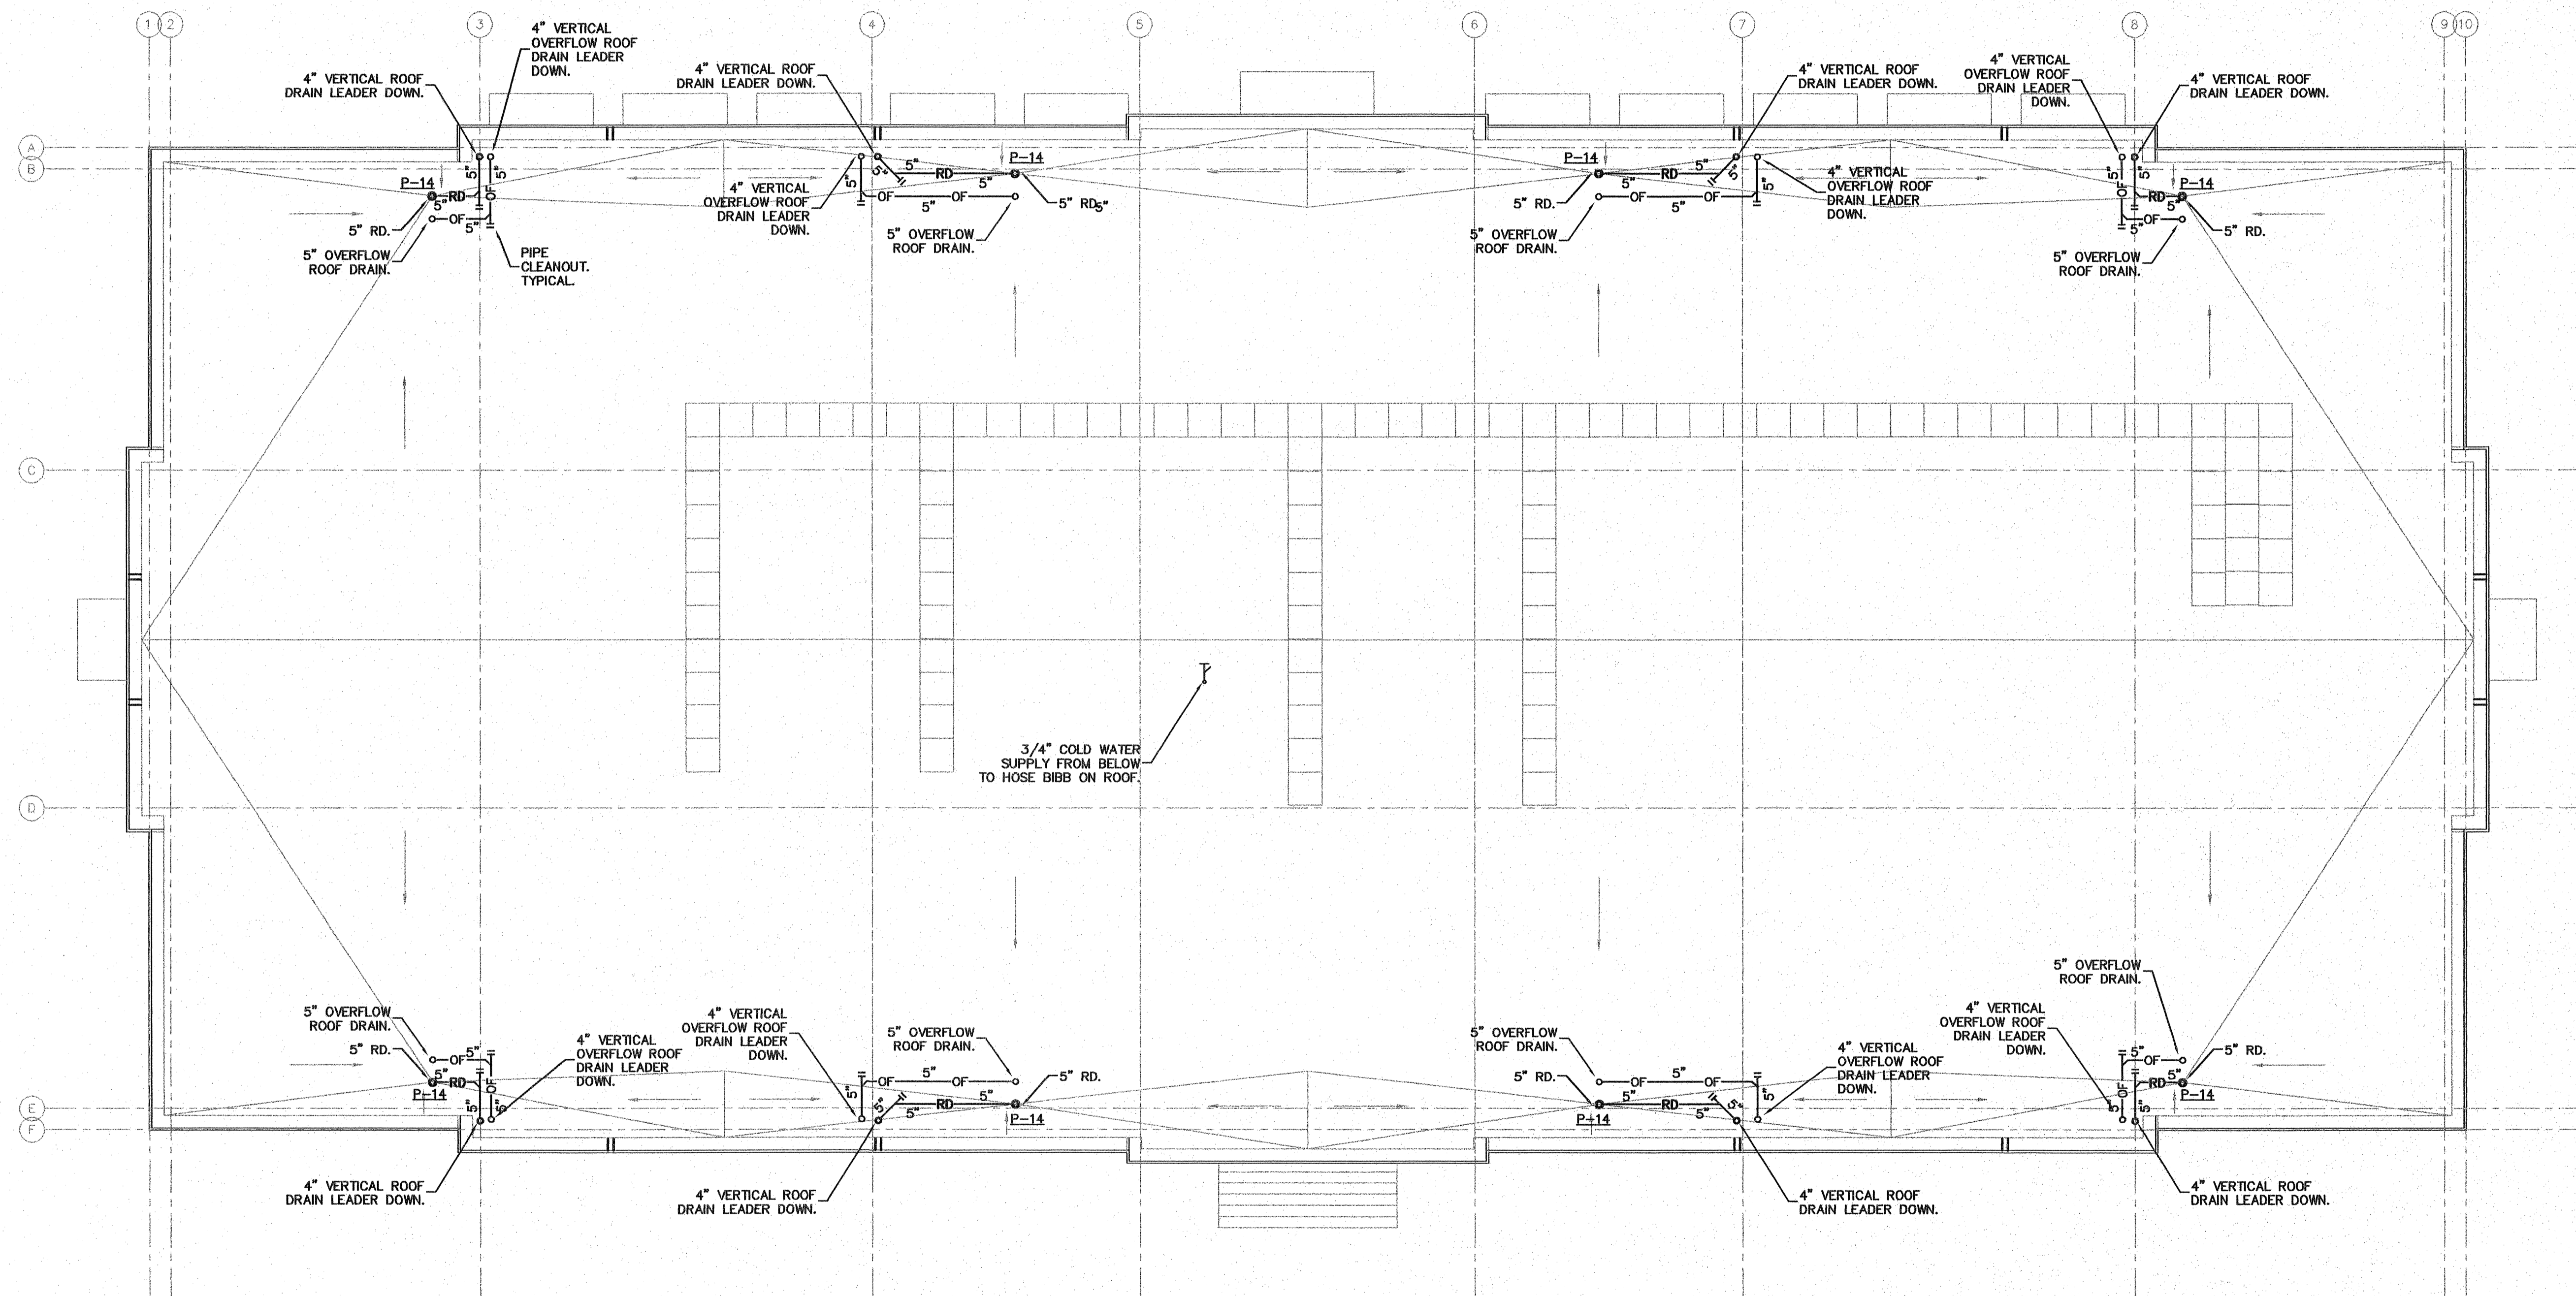

**OVERALL PLUMBING ROOF PLAN**  
 SCALE: 1/8" = 1' - 0"